


GENERAL NOTES

1. SEE DRG ELN 2111 SHT 719 FOR EMERGENCY LIGHTING IN MICROWAVE TOWER.

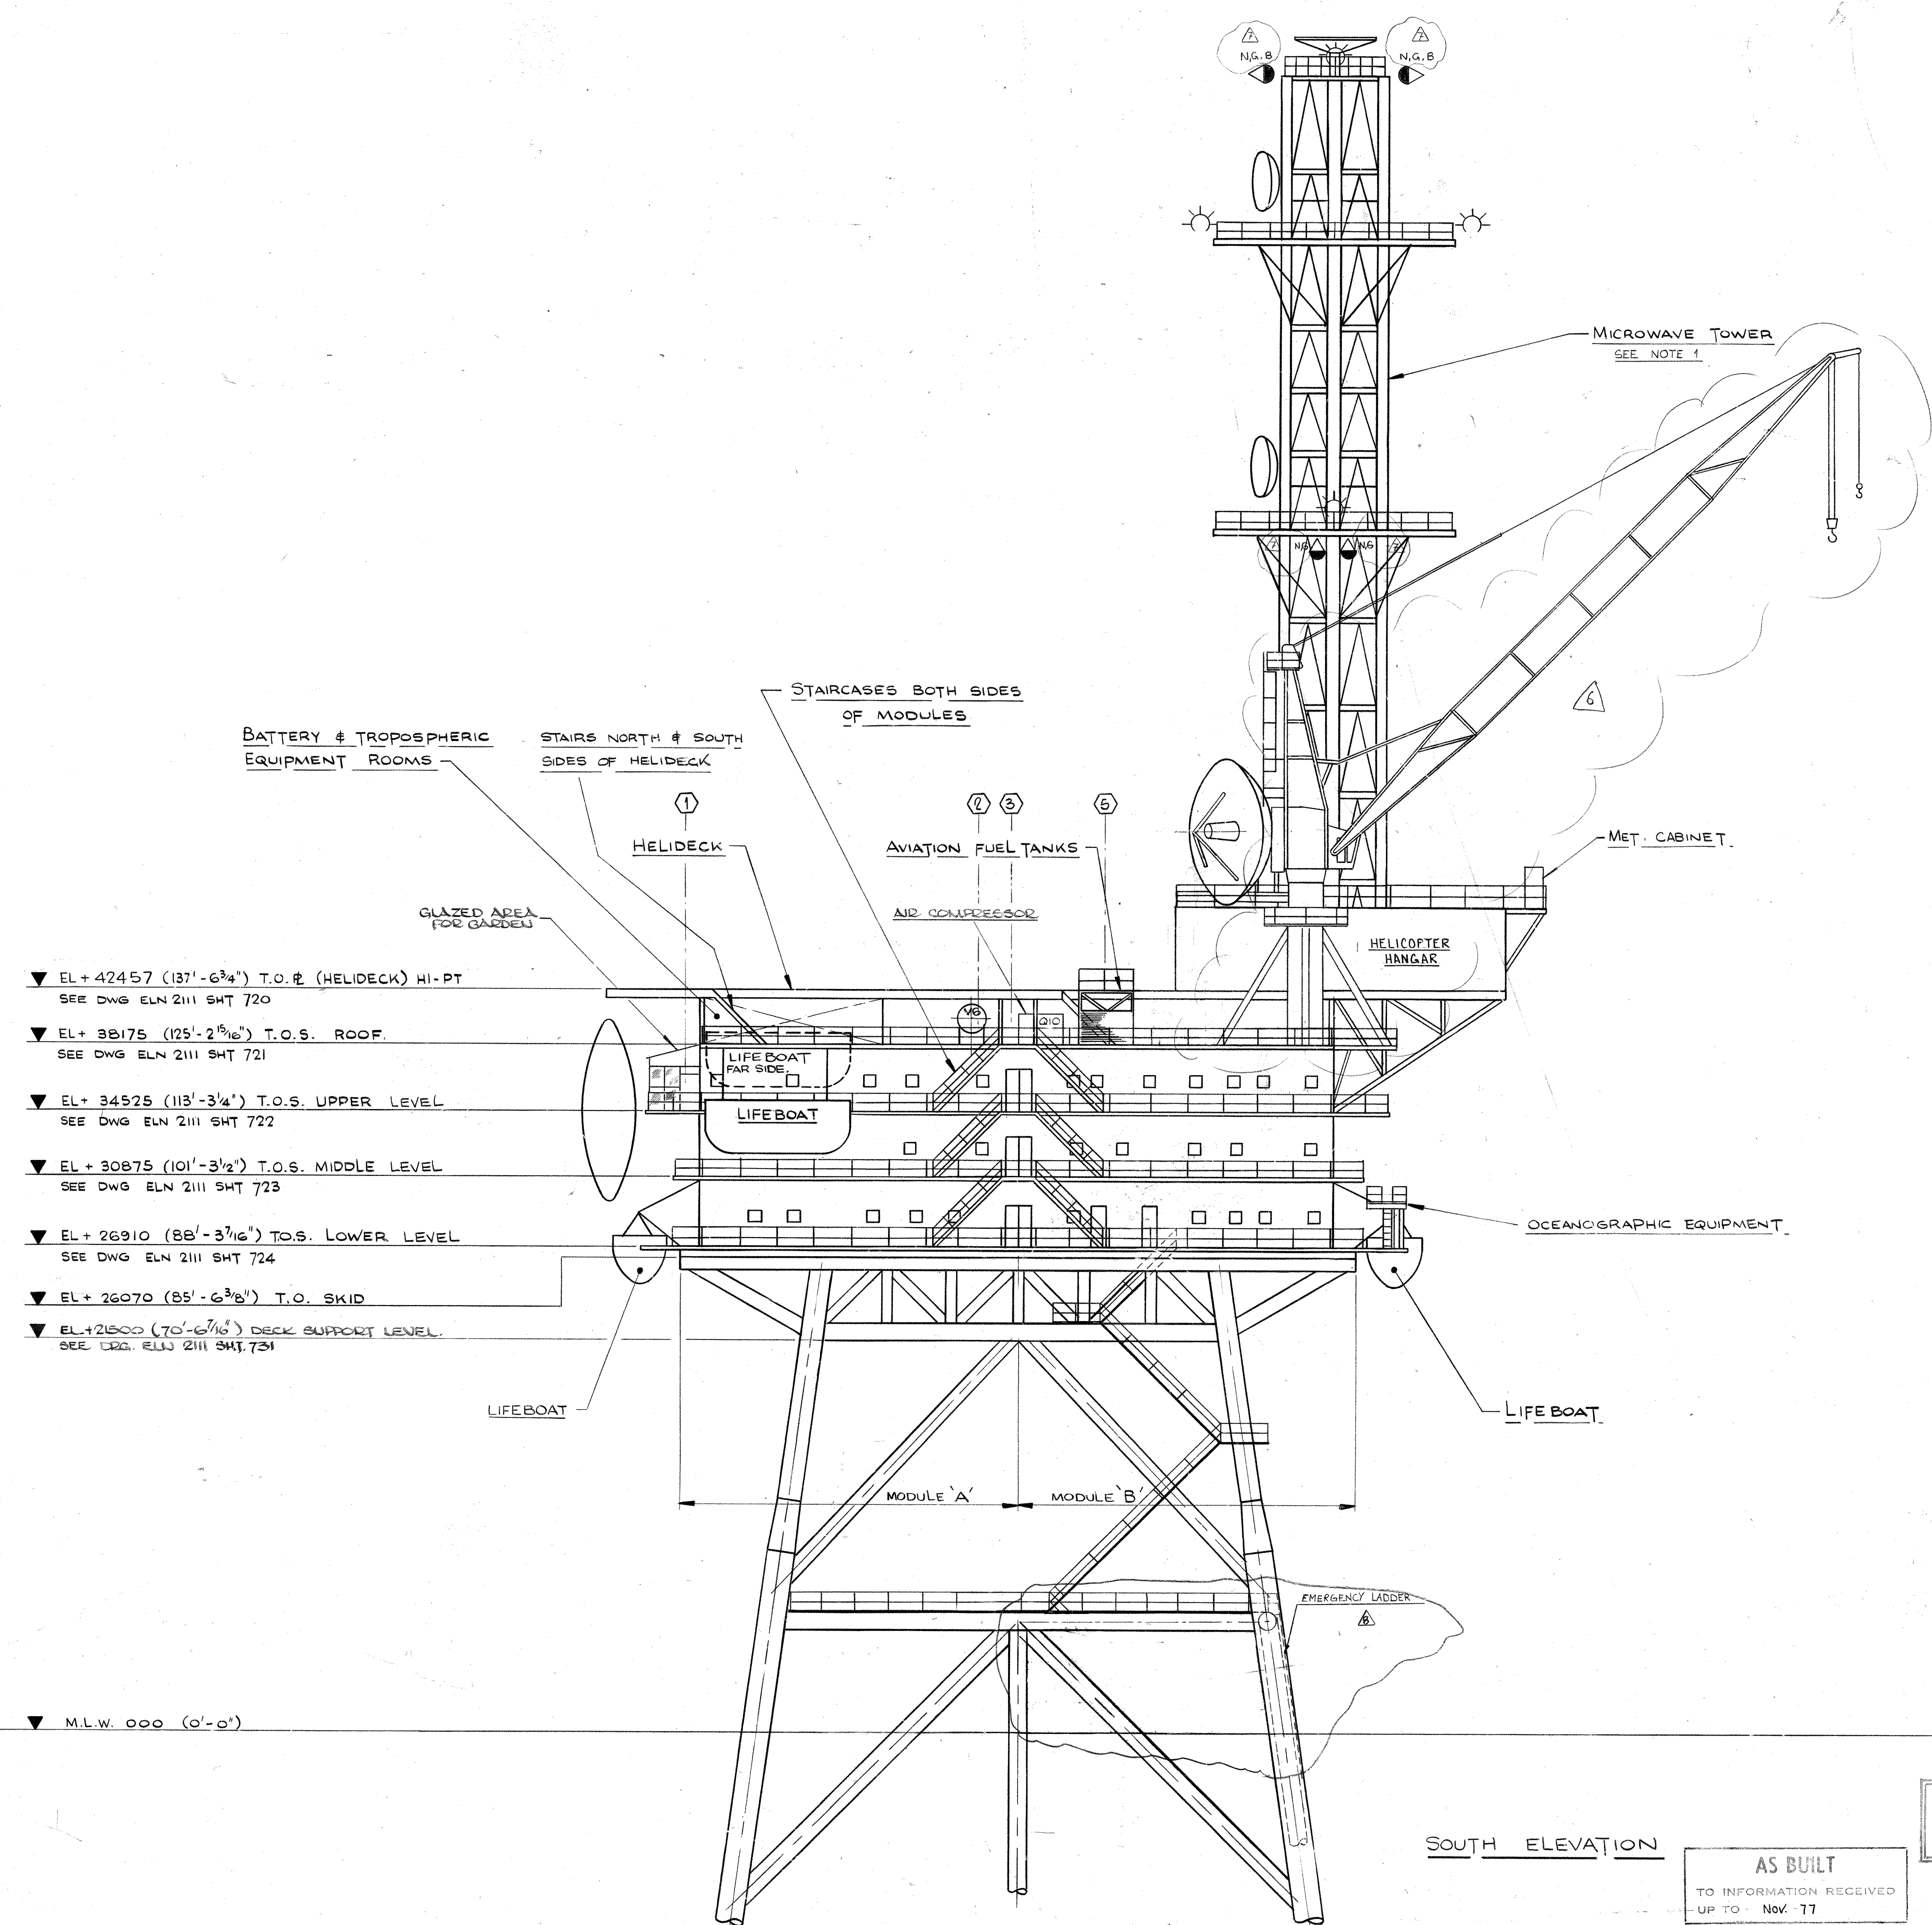

- ▼ EL+42457 (137'-6<sup>3</sup>/<sub>4</sub>") T.O. # (HELIDECK) HI-PT  
SEE DWG ELN 2111 SHT 720
- ▼ EL+ 38175 (125'-2<sup>15</sup>/<sub>16</sub>") T.O.S. ROOF  
SEE DWG ELN 2111 SHT 721
- ▼ EL+ 34525 (113'-3<sup>1</sup>/<sub>4</sub>') T.O.S. UPPER LEVEL  
SEE DWG ELN 2111 SHT 722
- ▼ EL+ 30875 (101'-3<sup>1</sup>/<sub>2</sub>') T.O.S. MIDDLE LEVEL  
SEE DWG ELN 2111 SHT 723
- ▼ EL+ 26910 (88'-3<sup>1</sup>/<sub>16</sub>") T.O.S. LOWER LEVEL  
SEE DWG ELN 2111 SHT 724
- ▼ EL+ 26070 (85'-6<sup>3</sup>/<sub>8</sub>') T.O. SKID
- ▼ EL+21500 (70'-6<sup>1</sup>/<sub>16</sub>") DECK SUPPORT LEVEL  
SEE DRG. ELN 2111 SHT 731

SOUTH ELEVATION

AS BUILT  
TO INFORMATION RECEIVED  
UP TO - Nov. 77

CUSTOMER APPROVAL  
BY: *[Signature]*  
DATE: 18.6.95

REFERENCE DRAWINGS

DRG N°	SHT. N°	TITLE
ELN2111	717	FIRE & SAFETY LAYOUT- LEGEND
ELN2111	719	- EAST ELEV.
ELN2111	720	- HELIDECK
ELN2111	721	- ROOF
ELN2111	722	- UPPER FLOOR
ELN2111	723	- MIDDLE FLOOR
ELN2111	724	- LOWER FLOOR
ELN 2111	731	- DECK SUPPORT LEVEL

ELF - NORGE  
FRIGG FIELD

QUARTERS PLATFORM  
JOB 1-40-D2

McDERMOTT - HUDSON  
LONDON - ENGLAND

APPROVED:	<i>[Signature]</i>
IN CHARGE:	<i>[Signature]</i>
DATE:	10/14/75
ENGINEER'S APPROVAL:	<i>[Signature]</i>

PROJECT:	ELF - NORGE
STRUCTURAL:	SK
MECHANICAL:	ME
ELECTRICAL:	EL
INSTRUMENT:	IS
PAV. CHECK:	PC
PROP. CHECK:	PP

DRAWN BY: C.A. GRIFFITHS  
SCALE: 1:150  
DATE: 27<sup>th</sup> JAN '75  
DWG. NO.: ELN 2111  
SHEET NO.: 718

FIRE & SAFETY LAYOUT - SOUTH ELEV. N.

DESIGN	STRUCT	PIPING	ELEC.	ME.	IS.	PC.	PP.	DATE	REVISIONS	DATE	APP.	DESIGN	STRUCT	PIPING	ELEC.	ME.	IS.	PC.	PP.	DATE	REVISIONS	DATE	APP.	
									7	D.F.	2-5-75	AD. N.G. & AND N.G. CLANK REVIS AS SHOWN AND DRAWING ISSUED AS BUILT.												
									10	J.D.	29-10-78	UPDATED												
									5	J.B.	26-10-77	SUPPRESSED WEST LADDER												
									8	S.M.	26-01-77	ADDED EMERGENCY LADDER - REPAIR BATHING												