



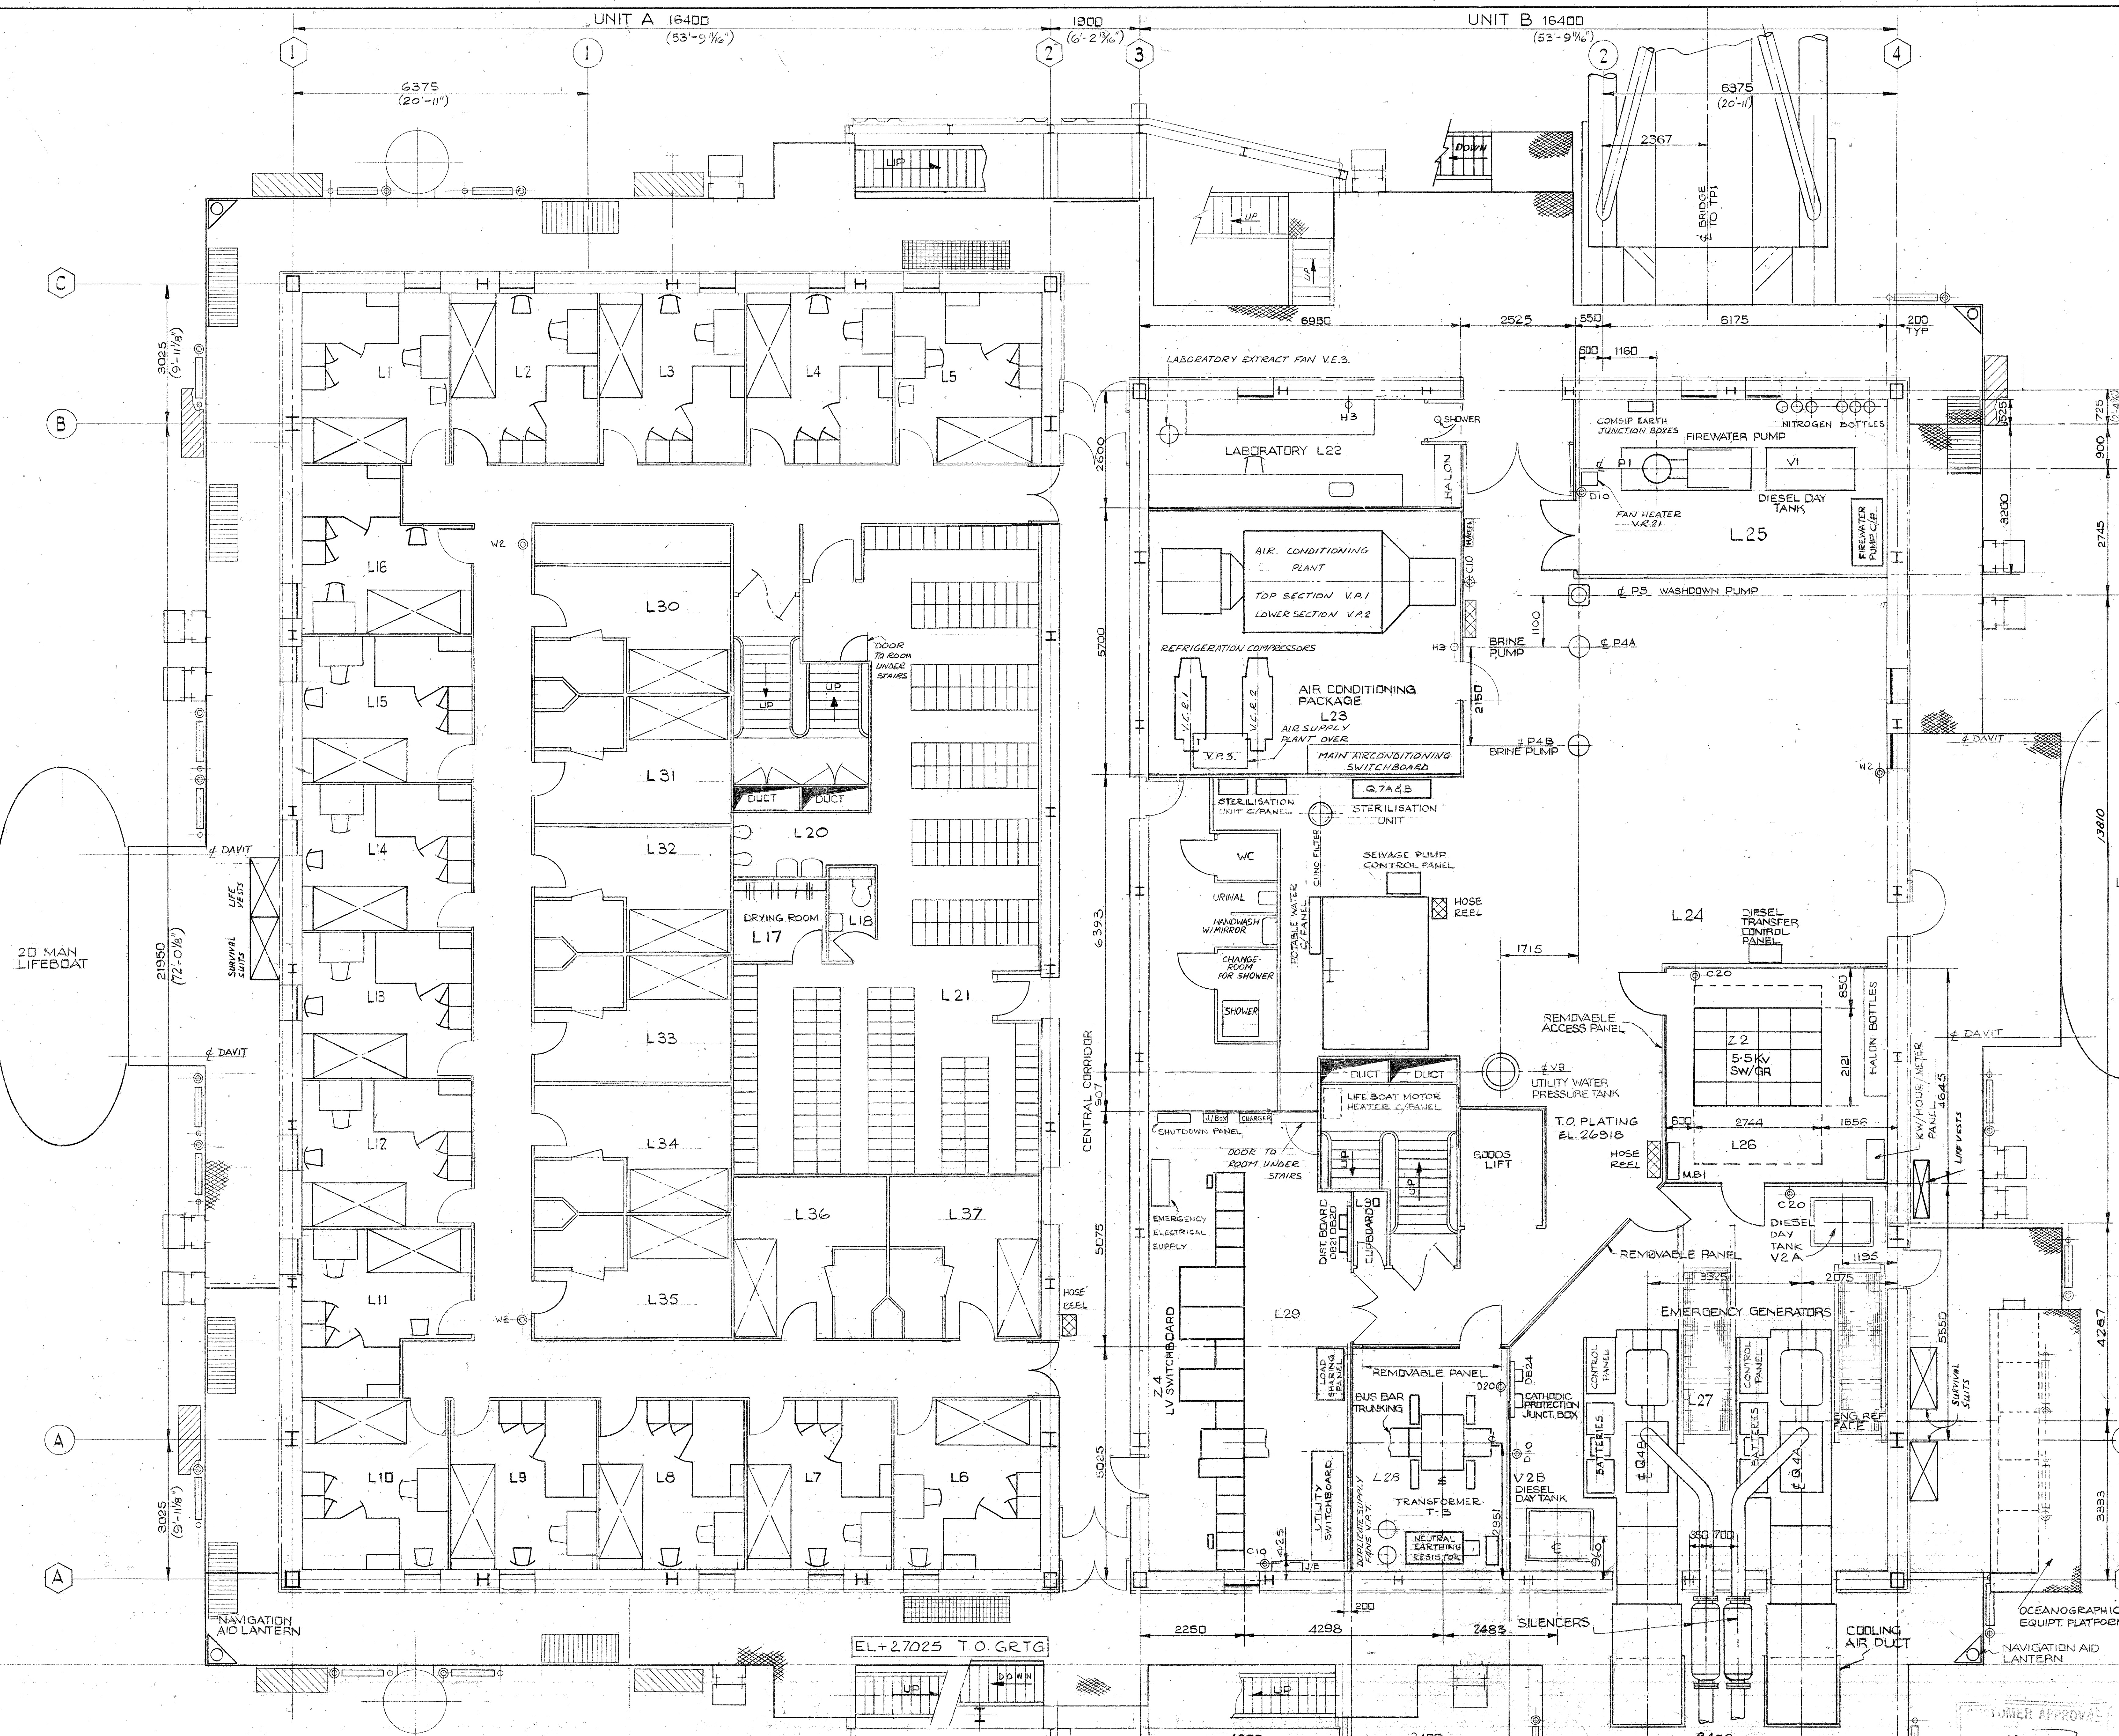

REFERENCE DRAWINGS
 PIPING ARRANGEMENT PLAN, MODULE 'B' (NORTH) ELN 2111-501
 " " " " (SOUTH) ELN 2111-502
 " " " " (SOUTH WALKWAY) ELN 2111-515
 " " " " " DRAINAGE, LOWER LEVEL ELN 2111-507
 LOWER FLOOR PLATING PLAN ELN 2098-327
 SPRINKLER LAYOUT MODULE A FF 96 20 01 1110
 SPRINKLER LAYOUT MODULE B FF 96 20 01 1101
 FIRE WATER PUMP MODULE A FF 96 20 01 1117
 GENERAL PLUMBING UNDER LOWER FLOOR FF 96 20 00 1033
 GENERAL PLUMBING UNDER LOWER FLOOR FF 96 20 00 1032
 GENERAL PLUMBING UNDER LOWER FLOOR FF 96 20 16 1113
 POTABLE AND SANITARY WATER FF 96 20 02 1139
 NEW ROOM SERVICE AREA OP ARRANGEMENT FF 96 00 00 0010

EQUIPMENT	DESCRIPTION	ELEVATION
H 1	INCINERATOR	U/S SKID EL. 26918
P 1	FIRE WATER PUMP	C DISCH. EL. 27350
P 4 A + B	BRINE PUMPS	DISCH. FOR F. EL. 11375
P 5	WASHDOWN PUMP	C DISCH. EL. 27318
P 6	SUMP PUMP	DISCH. FOR F. EL. 11101
Q 4 A + B	EMERGENCY DIESEL GENERATORS	C GENERATOR EL. 28129
Q 7 A	WATER STERILIZATION UNIT	U/S EL. 28400
Q 7 B	" " " "	U/S EL. 27500
Q 12	PROPANE BOTTLE RACK	U/S SKID EL. 26935
V 1	FIRE PUMP DIESEL DAY TANK	U/S TANK EL. 26518
V 2 A + B	GENERATOR DIESEL DAY TANKS	U/S TANK EL. 26918
V 5	SUMP CAISSON	FOR F. TOP DECKS EL. 27452
V 9	UTILITY WATER PRESSURE TANK	BTM. TAIL LINE EL. 27478

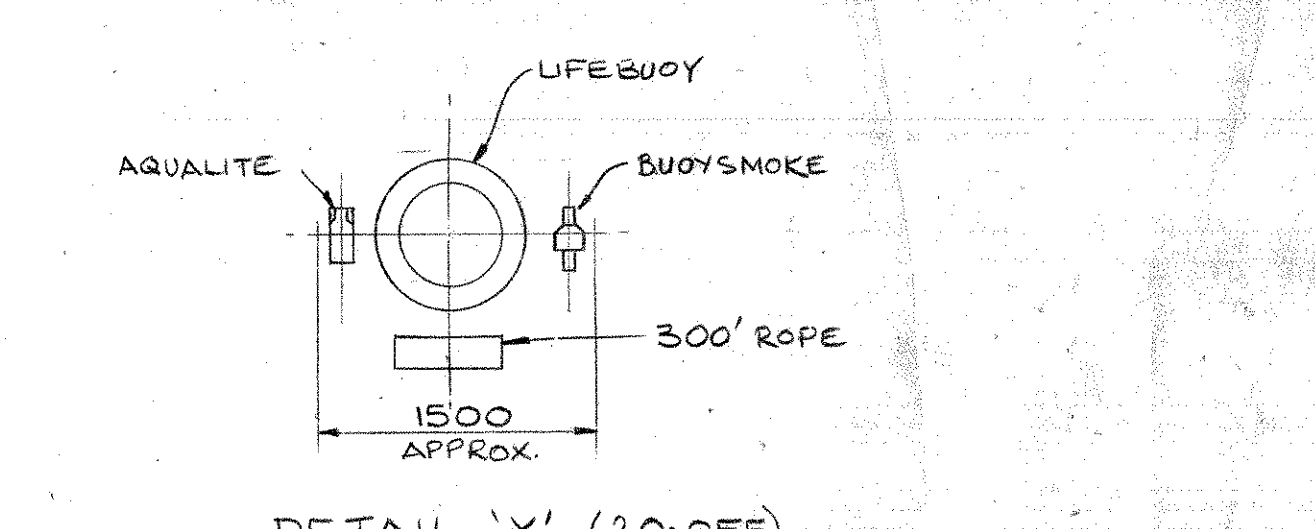

FIRE & SAFETY EQUIPMENT LEGEND

- LIFE BUOY (SEE DETAIL 'X')
- ROPE LADDER
- LIFE RAFT
- HOSE REEL
- 25 LIFE JACKETS
- FLOODLIGHT
- C 10 10 LBS CO2 FIRE EXTINGUISHER
- C 20 20 LBS " " " "
- D 10 10 LBS DRY POWDER FIRE EXTINGUISHER
- D 20 20 LBS " " " "
- H 3 3 LBS HALON FIRE EXTINGUISHER
- W 2 2-4 USG WATER/CO2 FIRE EXTINGUISHER

ELF - NORGE
FRIGG FIELD

QUARTERS PLATFORM
JOB 1-40-D2

MCDERMOTT - HUDSON
LONDON - ENGLAND

APPROVED: [Signature]
DATE: 3/11/76

ENGINEERS APPROVAL
BY: [Signature]
DATE: 6.3.76

PROJECT: [Blank]
STRUCTURAL: [Blank]
MECHANICAL: [Blank]
ELECTRICAL: [Blank]
INSTRUMENT: [Blank]
TANK CHECK: [Blank]
PIPE CHECK: [Blank]

DRAWN BY: [Blank]
SCALE: 1:50
DATE: 25 SEPT 1974
DESIGNED BY: [Blank]

DWG. NO. ELN 2111
SHEET NO. 459

OVERALL EQUIPMENT & ARCHITECTURAL FLOOR PLAN
LOWER LEVEL - EL. 26918

DESIGN	STRUCT	PIPING	ELEC.	MK.	BY	DATE	REVISIONS	DATE	APP.	DESIGN	STRUCT	PIPING	ELEC.	MK.	BY	DATE	REVISIONS	DATE	APP.
8	TJ	L 01/64	UPDATED 'AS BUILT'	3/10/74	CP					4	PC	1/6/76	AS BUILT REVISIONS AND REPAIRS						
9	KG	23.4.86	SEWAGE TREATMENT, Q2, REMOVED							5	PS	7/10/76	DISC. UPDATED AND INFORMATION FROM 2206/76						
10	RD	18.03.86	NEW ROOM SERVICE AREA OP							6	MD	21-11-77	REVISED 'AS BUILT'						
11	TB	7.5.90	UPDATED ACC. TO MV 9680							7	JM	16.3.93	REVISED TO 'AS BUILT' STATUS						