


NOTES :-


- 1 FOR PIPING PLAN INDEX SEE DRG. AI-TP-L658
- 2 FOR COMPLETE AND FINAL PIPEWORK DETAILS SEE PIPING ISOMETRICS A2-TP-S... SERIES

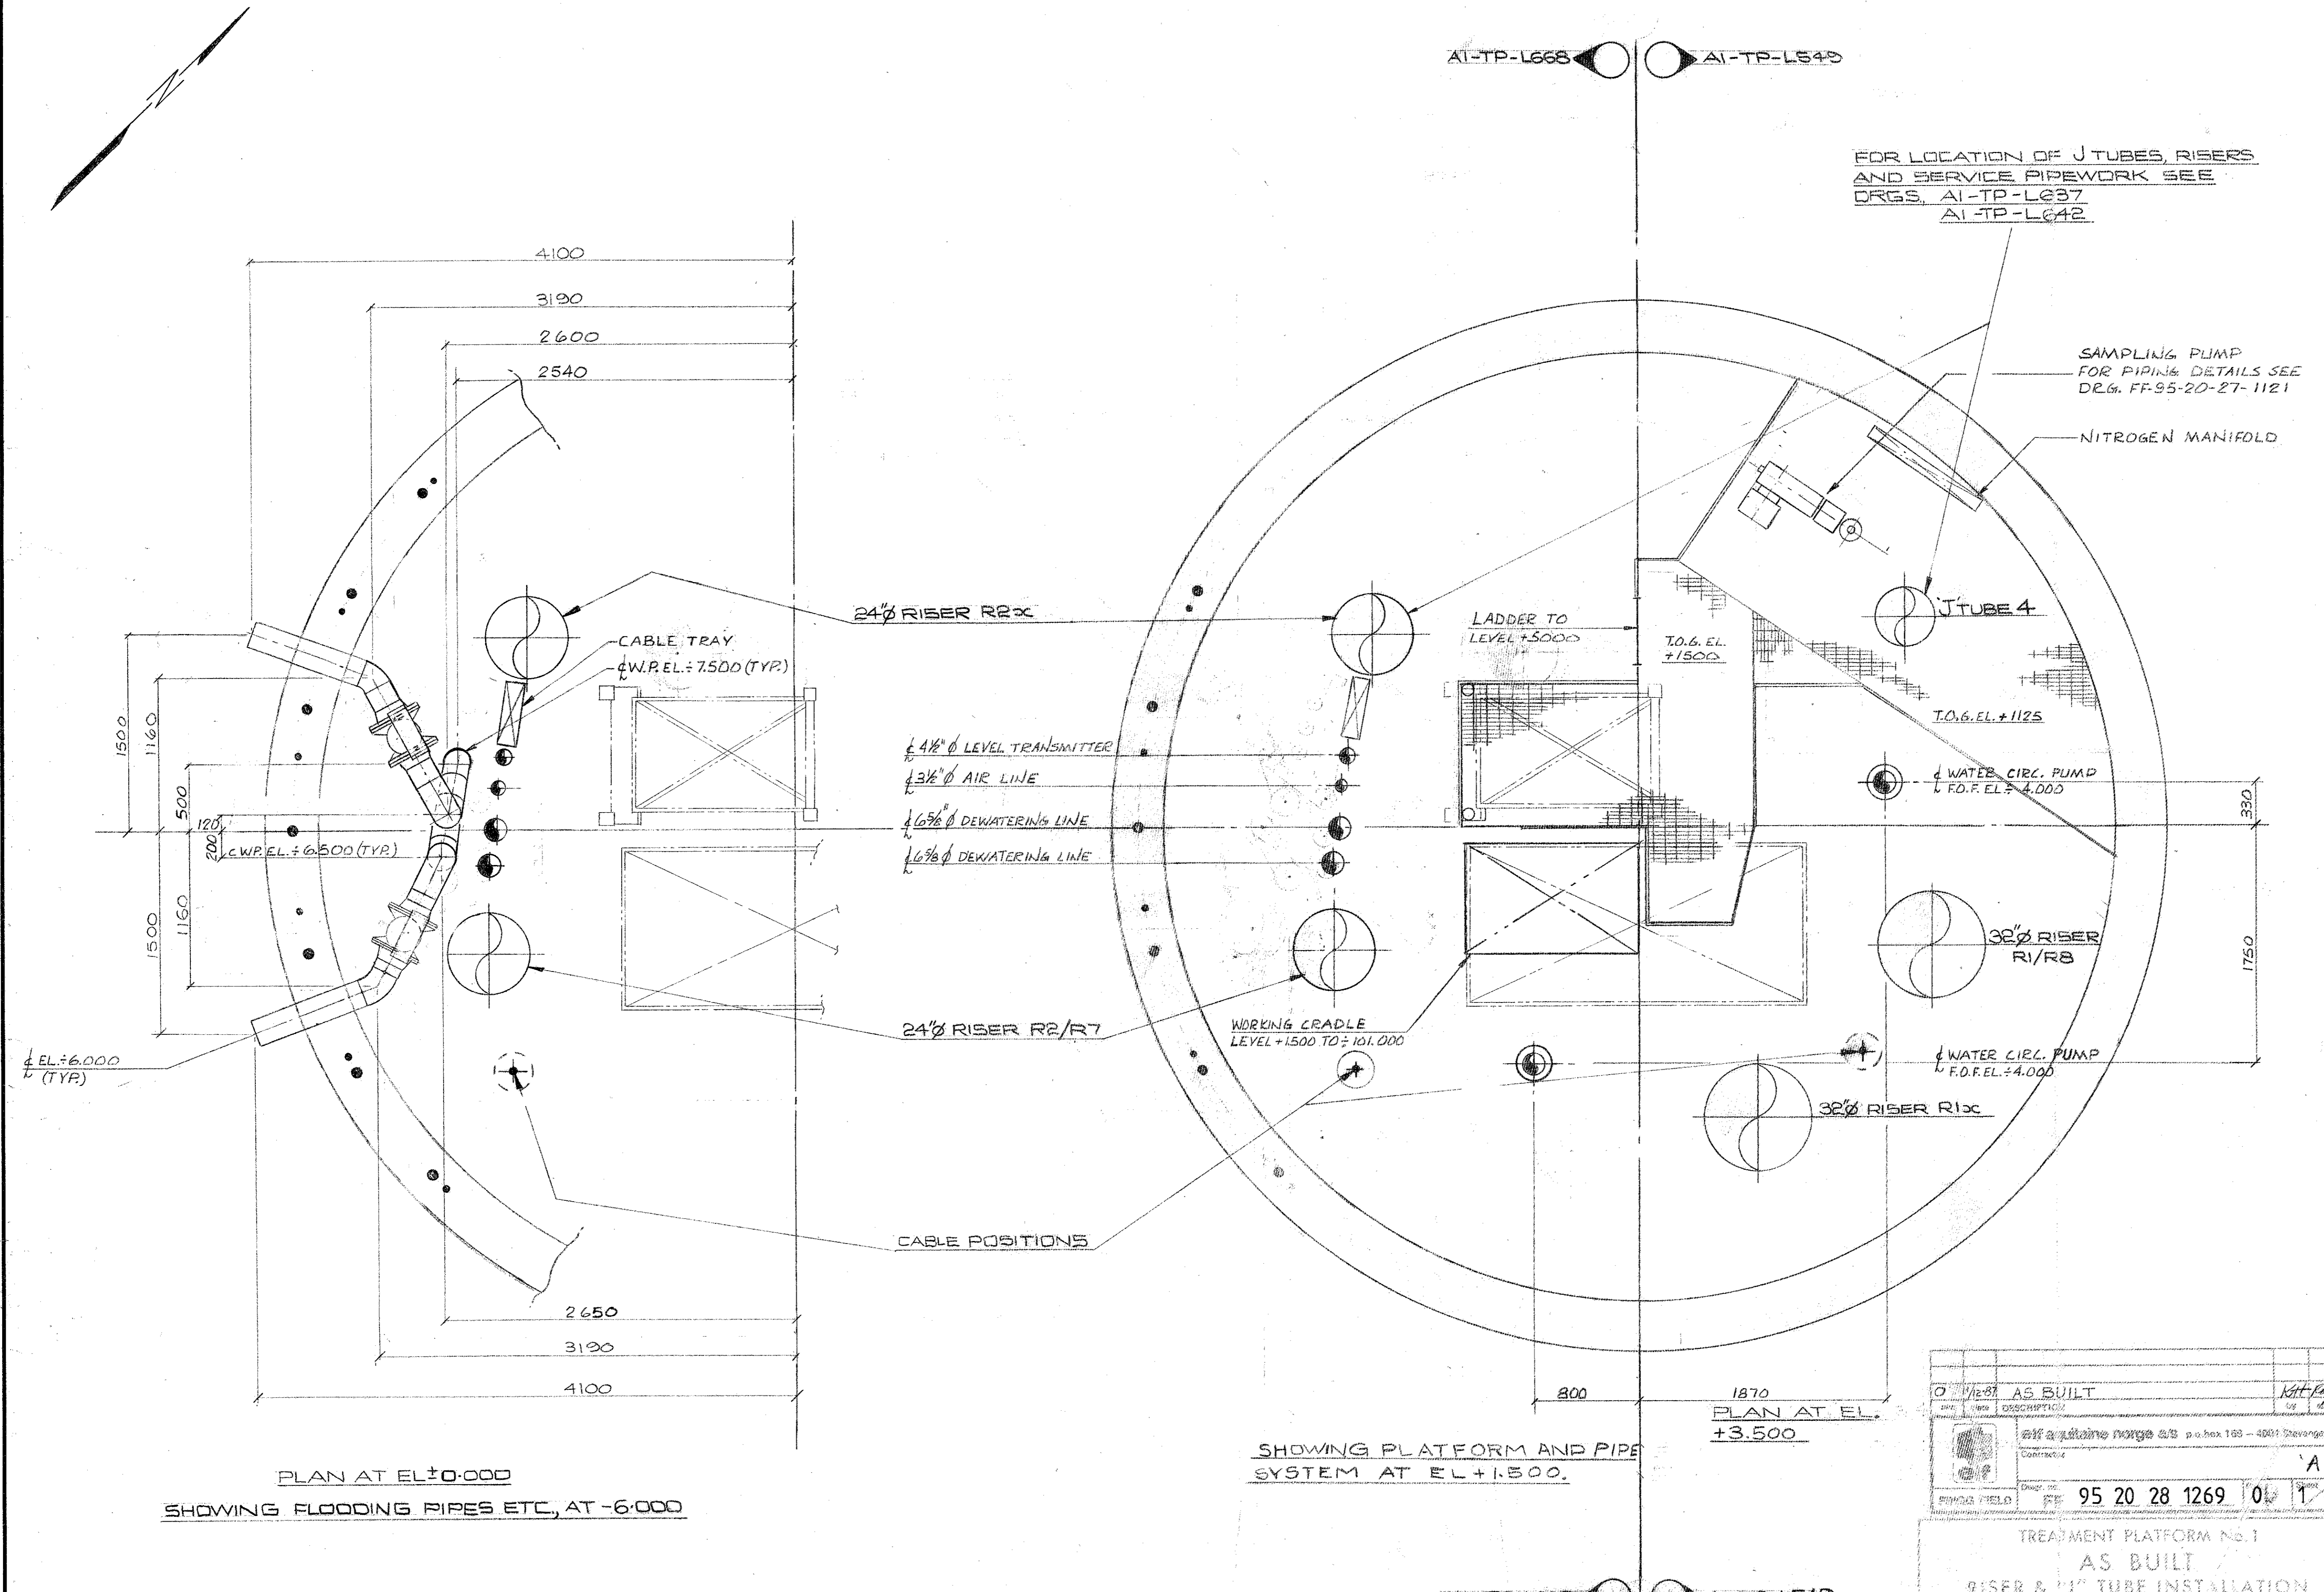

PLAN AT EL ±0.000
SHOWING FLOODING PIPES ETC., AT -6.000

SHOWING PLATFORM AND PIPE SYSTEM AT EL +1.500.

REV. NO.	DESCRIPTION	DATE	BY
0	AS BUILT		
1	elf a/lutane Norge AS p.o. box 165 - 4001 Steingårde		
PROJECT No. 95 20 28 1269			
DRAWING No. 01 1/1			
TREATMENT PLATFORM No. 1			
AS BUILT			
RISER & 'J' TUBE INSTALLATION			

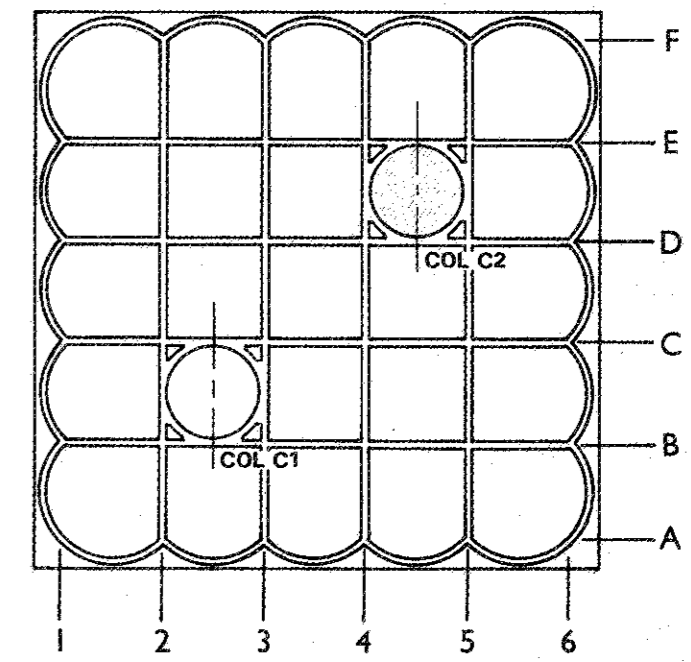

KEY-PLAN

PHASE I

Brown & Root, (U.K.) Ltd.
Engineers, Constructors
LONDON, ENGLAND.

TREATMENT PLATFORM No. 1
PLAN OF FLOODING/DEWATERING
BYPASS ARRET. AT EL -6.000 &
+1.500 COLUMN C2

elf NORGE - A/S
FRIGG FIELD DEVELOPMENT PROJECT

NUMBER	TITLE	REV. NO.	REVISION	BY	DATE	CHKD
AI-TP-L659	FLOODING, DEWATERING, FLOWSHEET	A	ADDED "AS BUILT"	AF	21/3/77	

BY	DATE	CHECKED	DATE	APPROVED	DATE
RTAYLOR	29-1-75	M.H.	25 June 75	[Signature]	20 June 1975

SCALE	PROJECT No.	DRAWING NUMBER	REV.
1:25	78-5711	AI-TP-L666	A